

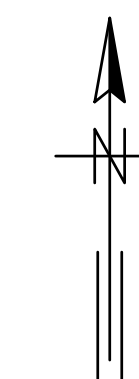


CITY OF RICHMOND, VIRGINIA DEPARTMENT OF PUBLIC WORKS

FIRE DEPARTMENT TRAINING FACILITY PROJECT

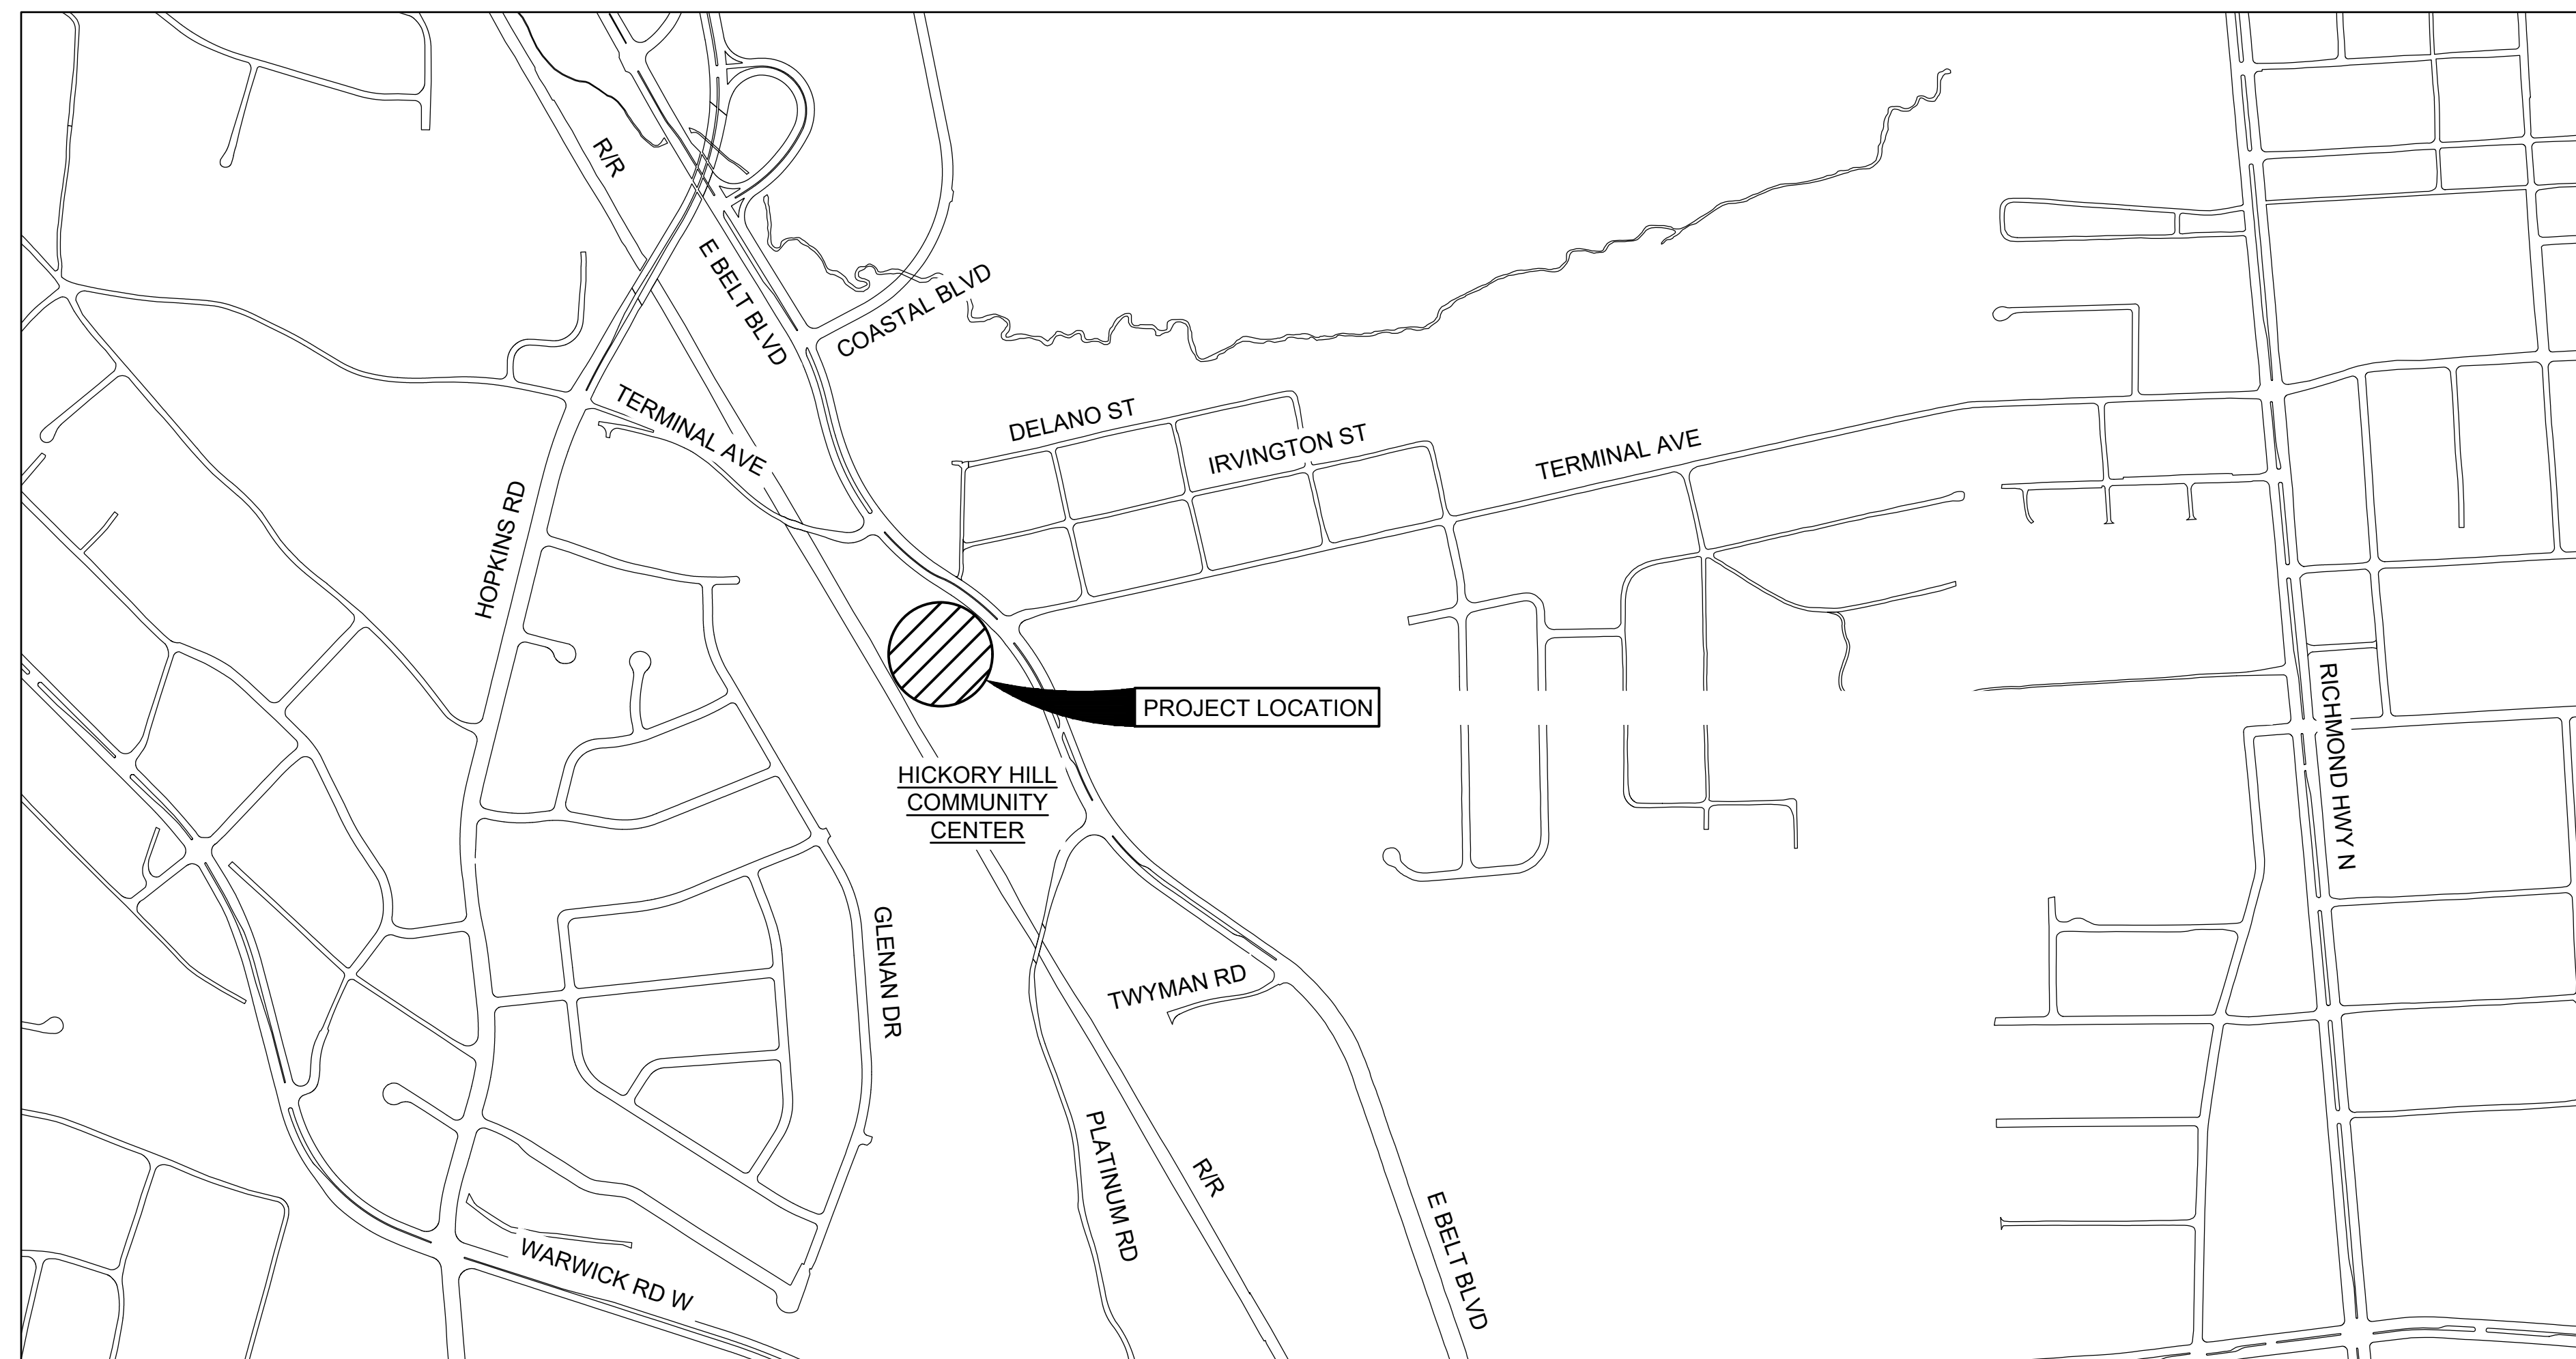

VICINITY MAP

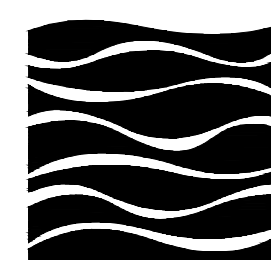

GREELEY AND HANSEN

9020 STONY POINT PARKWAY, SUITE 275
RICHMOND, VIRGINIA 23235

IN ASSOCIATION WITH

ECE **Environ-Civil Engineering, Ltd.**
 Engineers • Scientists • Construction Managers
 2108 W Laburnum Avenue, Suite 250 Richmond, VA 23227

DANIELS & ASSOCIATES, P.C.
 Consulting Engineers
 808 Moorefield Park Drive, Suite 105
 Richmond, Virginia 23236

PROJECT ADDRESS

3000 EAST BELT BOULEVARD
RICHMOND, VA 23234
PARCEL ID: C0090612020

OWNER CONTACT


LOUIS D. GOODE
CITY OF RICHMOND DEPARTMENT OF PUBLIC WORKS
900 EAST BROAD STREET - RM. 602
RICHMOND, VA 23219
PHONE: (804) 646-7531

DPU CONTACT

LOUIS D. GOODE
CITY OF RICHMOND DEPARTMENT OF PUBLIC WORKS
900 EAST BROAD STREET - RM. 602
RICHMOND, VA 23219
PHONE: (804) 646-7531

NOVEMBER 2022

90% SUBMITTAL
NOT FOR CONSTRUCTION

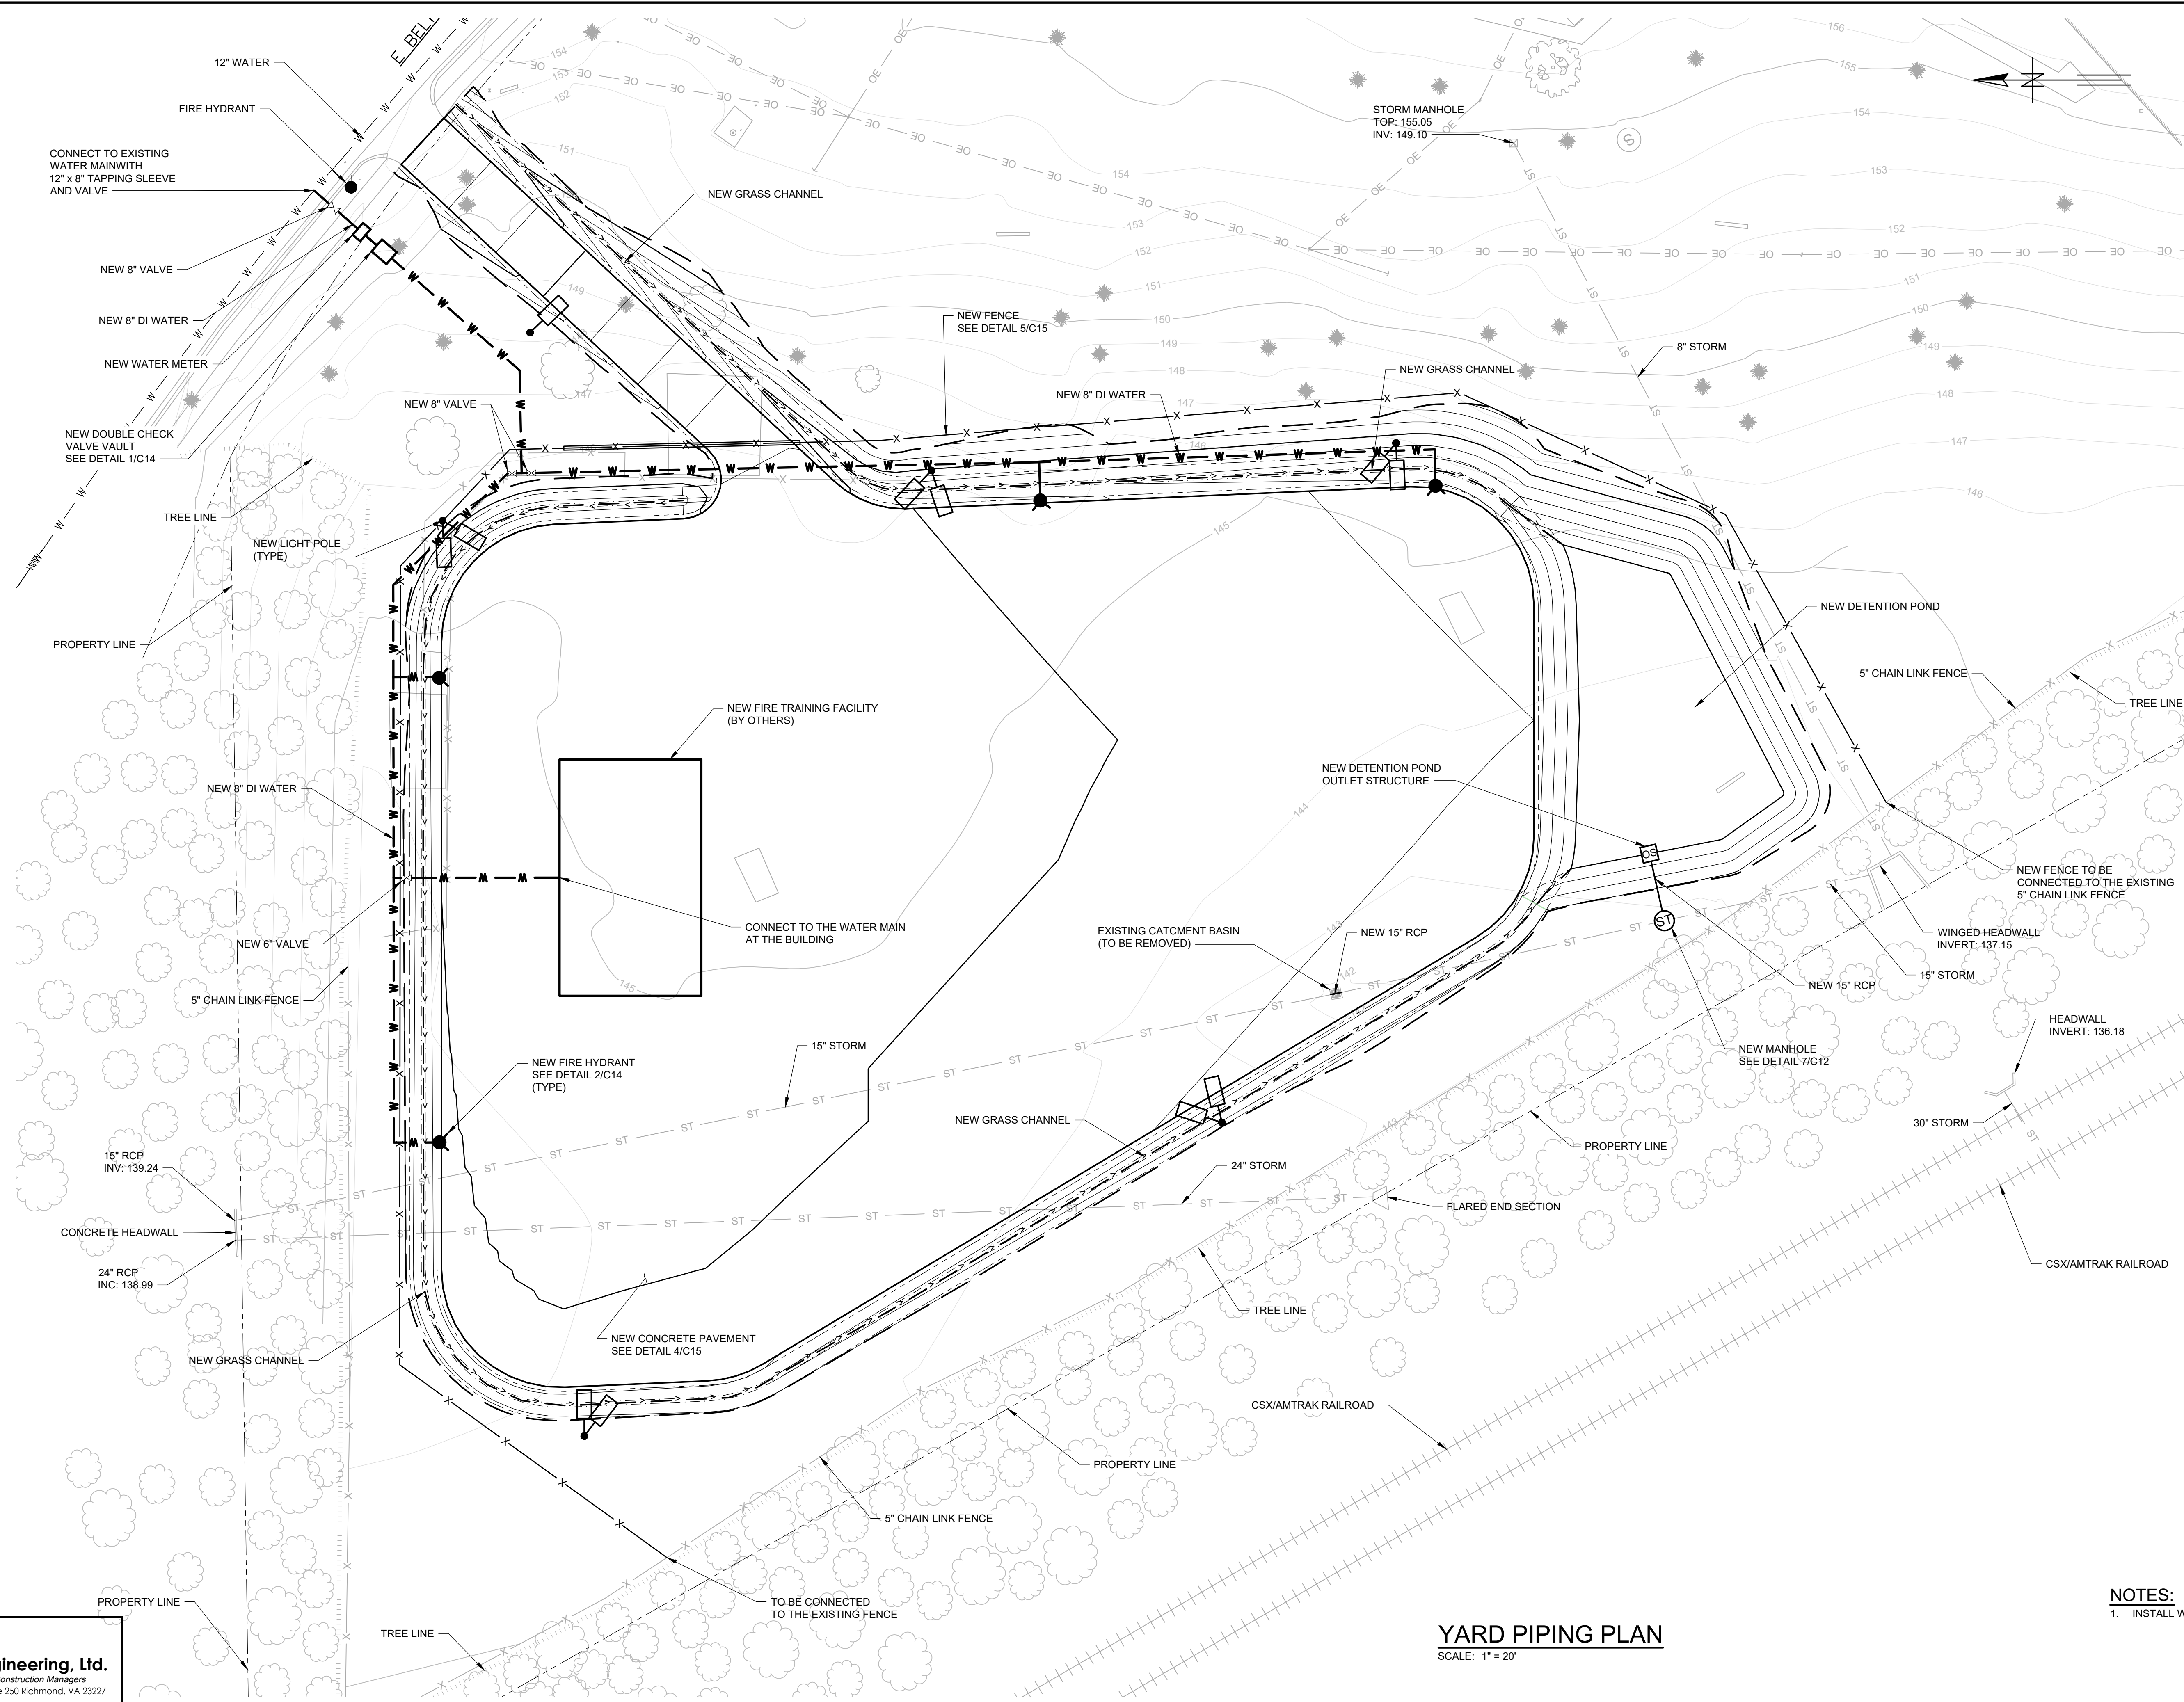


NOTES:
 1. INSTALL WATER MAIN 3.5' (MIN) BELOW FINISHED GRADE

YARD PIPING PLAN
 SCALE: 1" = 20'

EC Environ-Civil Engineering, Ltd.
 Engineers • Scientists • Construction Managers
 2108 W Laburnum Avenue, Suite 250 Richmond, VA 23227

GREELEY AND HANSEN
 9020 STONY POINT PARKWAY, SUITE 275
 RICHMOND, VIRGINIA 23235


DESIGNED	XXX				
DRAWN	XXX				
CHECKED	XXX				
APPROVED					
NO.	DATE	APPD	REVISION DESCRIPTION		

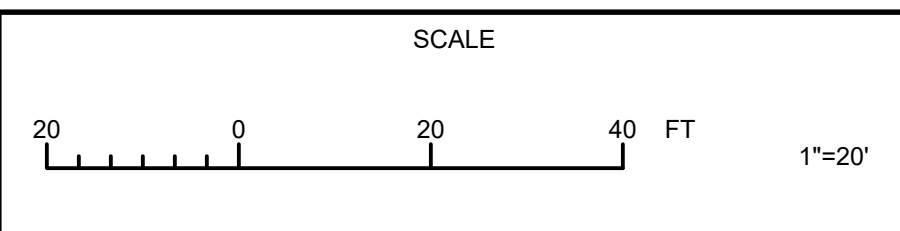

CITY OF RICHMOND, VIRGINIA
 DEPARTMENT OF PUBLIC UTILITIES
RICHMOND FIRE DEPARTMENT
 TRAINING FACILITY



CIVIL
 CIVIL YARD PIPING PLAN
 PROJECT NO.: 0218A-09
 DWG: **C11**
 SHEET: 13 OF XX
 DATE: NOVEMBER 2022 REV: 0

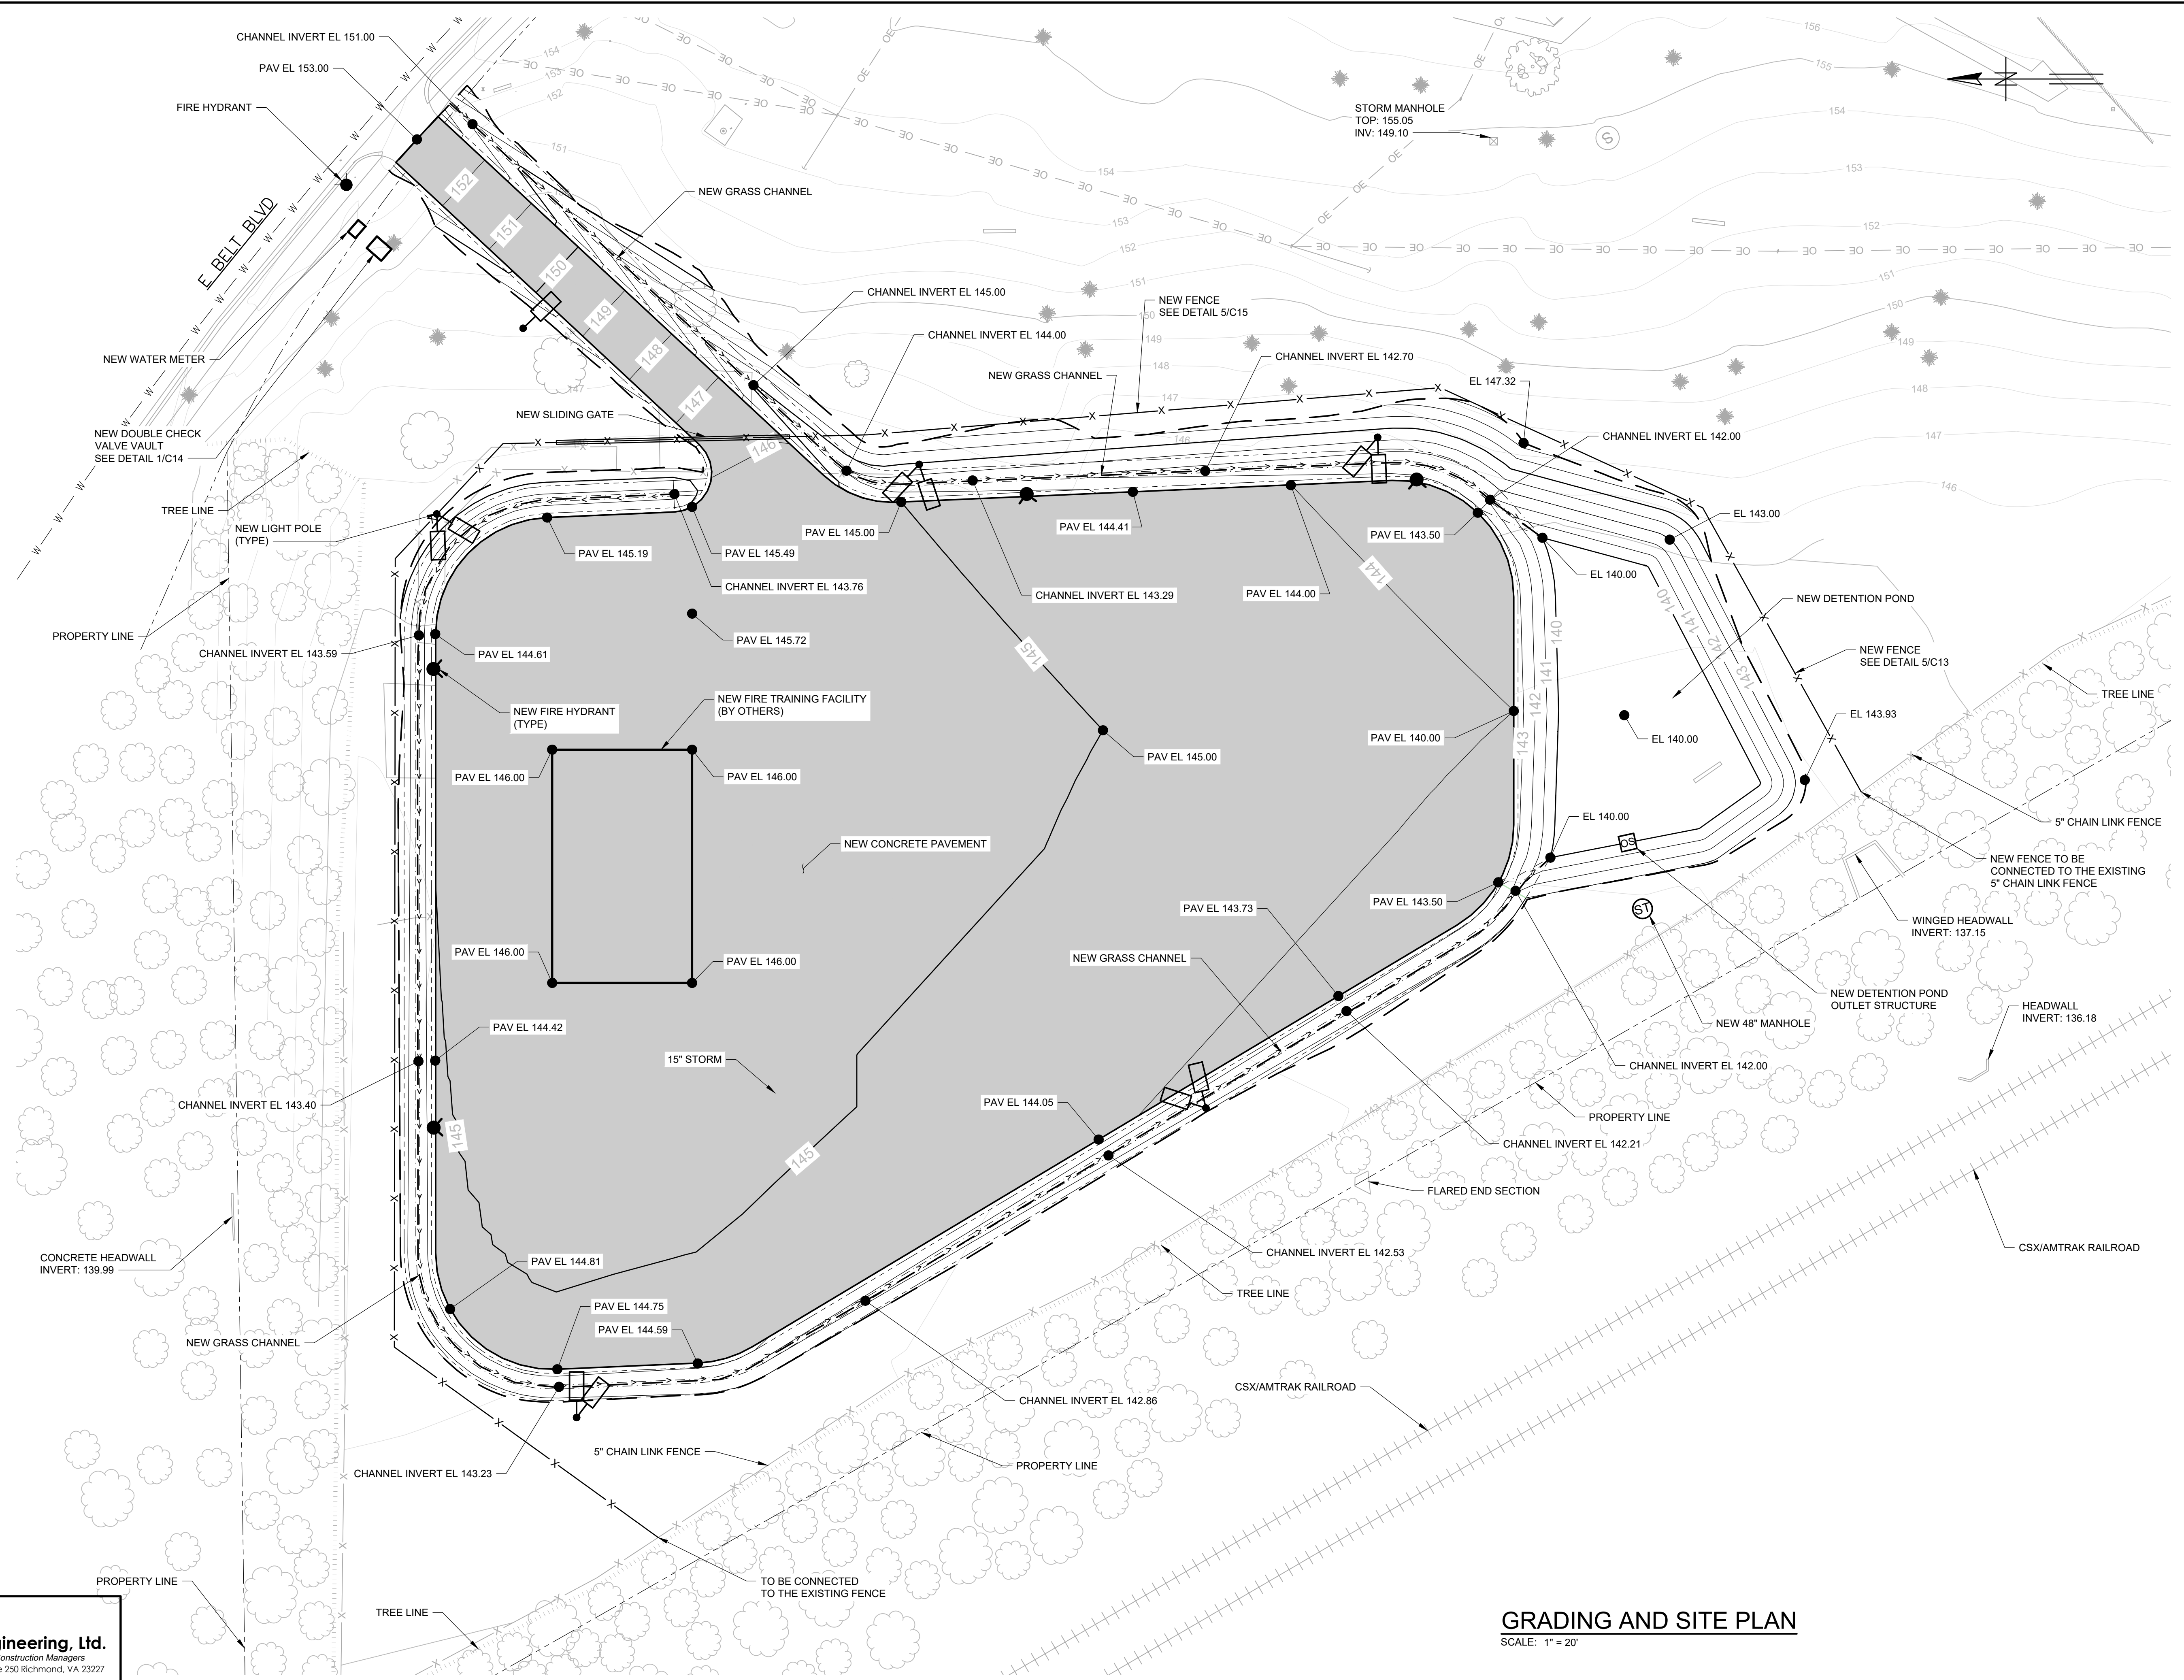


GRADING AND SITE PLAN
SCALE: 1" = 20'

EC Environ-Civil Engineering, Ltd.
Engineers • Scientists • Construction Managers
2108 W Laburnum Avenue, Suite 250 Richmond, VA 23227

GREELEY AND HANSEN
9020 STONY POINT PARKWAY, SUITE 275
RICHMOND, VIRGINIA 23235

DESIGNED XXX
DRAWN XXX
CHECKED XXX
APPROVED

NO.	DATE	APPD	REVISION DESCRIPTION

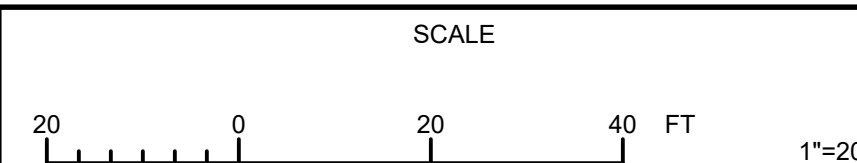

CITY OF RICHMOND, VIRGINIA
DEPARTMENT OF PUBLIC UTILITIES
**RICHMOND FIRE DEPARTMENT
TRAINING FACILITY**



CIVIL
CIVIL SITE GRADING PLAN

PROJECT NO.: 0218A-09
DWG: **C12**
SHEET: 14 OF XX
DATE: NOVEMBER 2022 REV: 0